


○ ADA MOUNTING HEIGHTS
3/8" = 1'-0"

TOILET ACCESSORY SCHEDULE		MOUNTING HEIGHT: SEE ADA MOUNTING HEIGHT DIAGRAM		
TAG	FIXTURE OR ACCESSORY	MANUF.	DESIGN BASIS MODEL #	REMARKS
A-1	42" HORIZONTAL GRAB BAR	BOBRICK	B-5806 99 X 42	PEENED GRIP STAINLESS STEEL
A-2	36" HORIZONTAL GRAB BAR	BOBRICK	B-5806 99 X 36	PEENED GRIP STAINLESS STEEL
A-3	SHOWER GRAB BAR	BOBRICK	B-6661	HORIZONTAL TWO-WALL BAR FOR SHOWER STALL
A-4	SHOWER CURTAIN AND HOOKS	BOBRICK	BOB-204-2 & 204-1	42" W X 72" H, PROVIDE 7 HOOKS
A-5	SHOWER CURTAIN ROD	BOBRICK	B-6107 X 36	—
A-6	COMBINATION TOILET AND LAVATORY UNIT	WILLOUGHBY	3690-GBC SERIES	ADA COMPLIANT - 36" WIDE, (90 DEGREES CHASE) W/ ANTI-SUICIDE GRAB BAR AND CLOSURE PLATE
A-7	MIRROR	BOBRICK	B-165 SERIES #4248	
A-8	CHANGING ROOM MIRROR 24" X 60"	BOBRICK	B-165 SERIES #2460	
A-9	H.C. SHOWER BENCH	SEE SPECS	B-5181	REVERSIBLE FOLDING SHOWER SEAT
A-10	WALL MOUNTED SOAP DISPENSER	BOBRICK	B-2111	
A-11	WALL MOUNTED PAPER TOWEL DISPENSER	BOBRICK	BOB-262	
A-12	WALL MOUNTED TOILET TISSUE DISPENSER	BOBRICK	BOB-2888	
A-13	DETENTION STYLE TOILET TISSUE DISPENSER	BRADLEY	3A 11	—
A-14	UTILITY HOOK / TOWEL PIN	BOBRICK	B-7672	
A-15	STAINLESS STEEL FRAMELESS MIRROR	BOBRICK	B-1556	
A-16	MOP AND BUCKET HOLDER	BOBRICK	B-223-36	
A-17	42" HORIZ. LIGATURE RESISTANT GRAB BAR	BRADLEY	5A70 SERIES	1 1/2" DIA STAINLESS STEEL

NOTES:

1. REFER TO LIFE SAFETY DRAWING FOR PLUMBING FIXTURE COUNTS
2. REFER TO TOILET STALL TYPES FOR TYPICAL ACCESSORIES WHERE NOT INDICATED ON PLANS.
3. WHERE MOUNTING HEIGHTS ARE NOT INDICATED INSTALL IN ACCORDANCE WITH GUIDELINES IN 2012 FLORIDA ACCESSIBILITY CODE FOR BUILDINGS CONSTRUCTION.
4. IF MOUNTING CONFLICTS OCCUR - COORDINATE MOUNTING LOCATION WITH ARCHITECT.
5. REFER TO ADA MOUNTING HEIGHTS DETAILS IN THIS DOCUMENT FOR ADDITIONAL MOUNTING HEIGHTS NOT LISTED ON TOILET ACCESSORY SCHEDULE.
6. ALL ACCESSORIES MUST BE ANTI-LIGATURE WITH NO HANG HOLES.

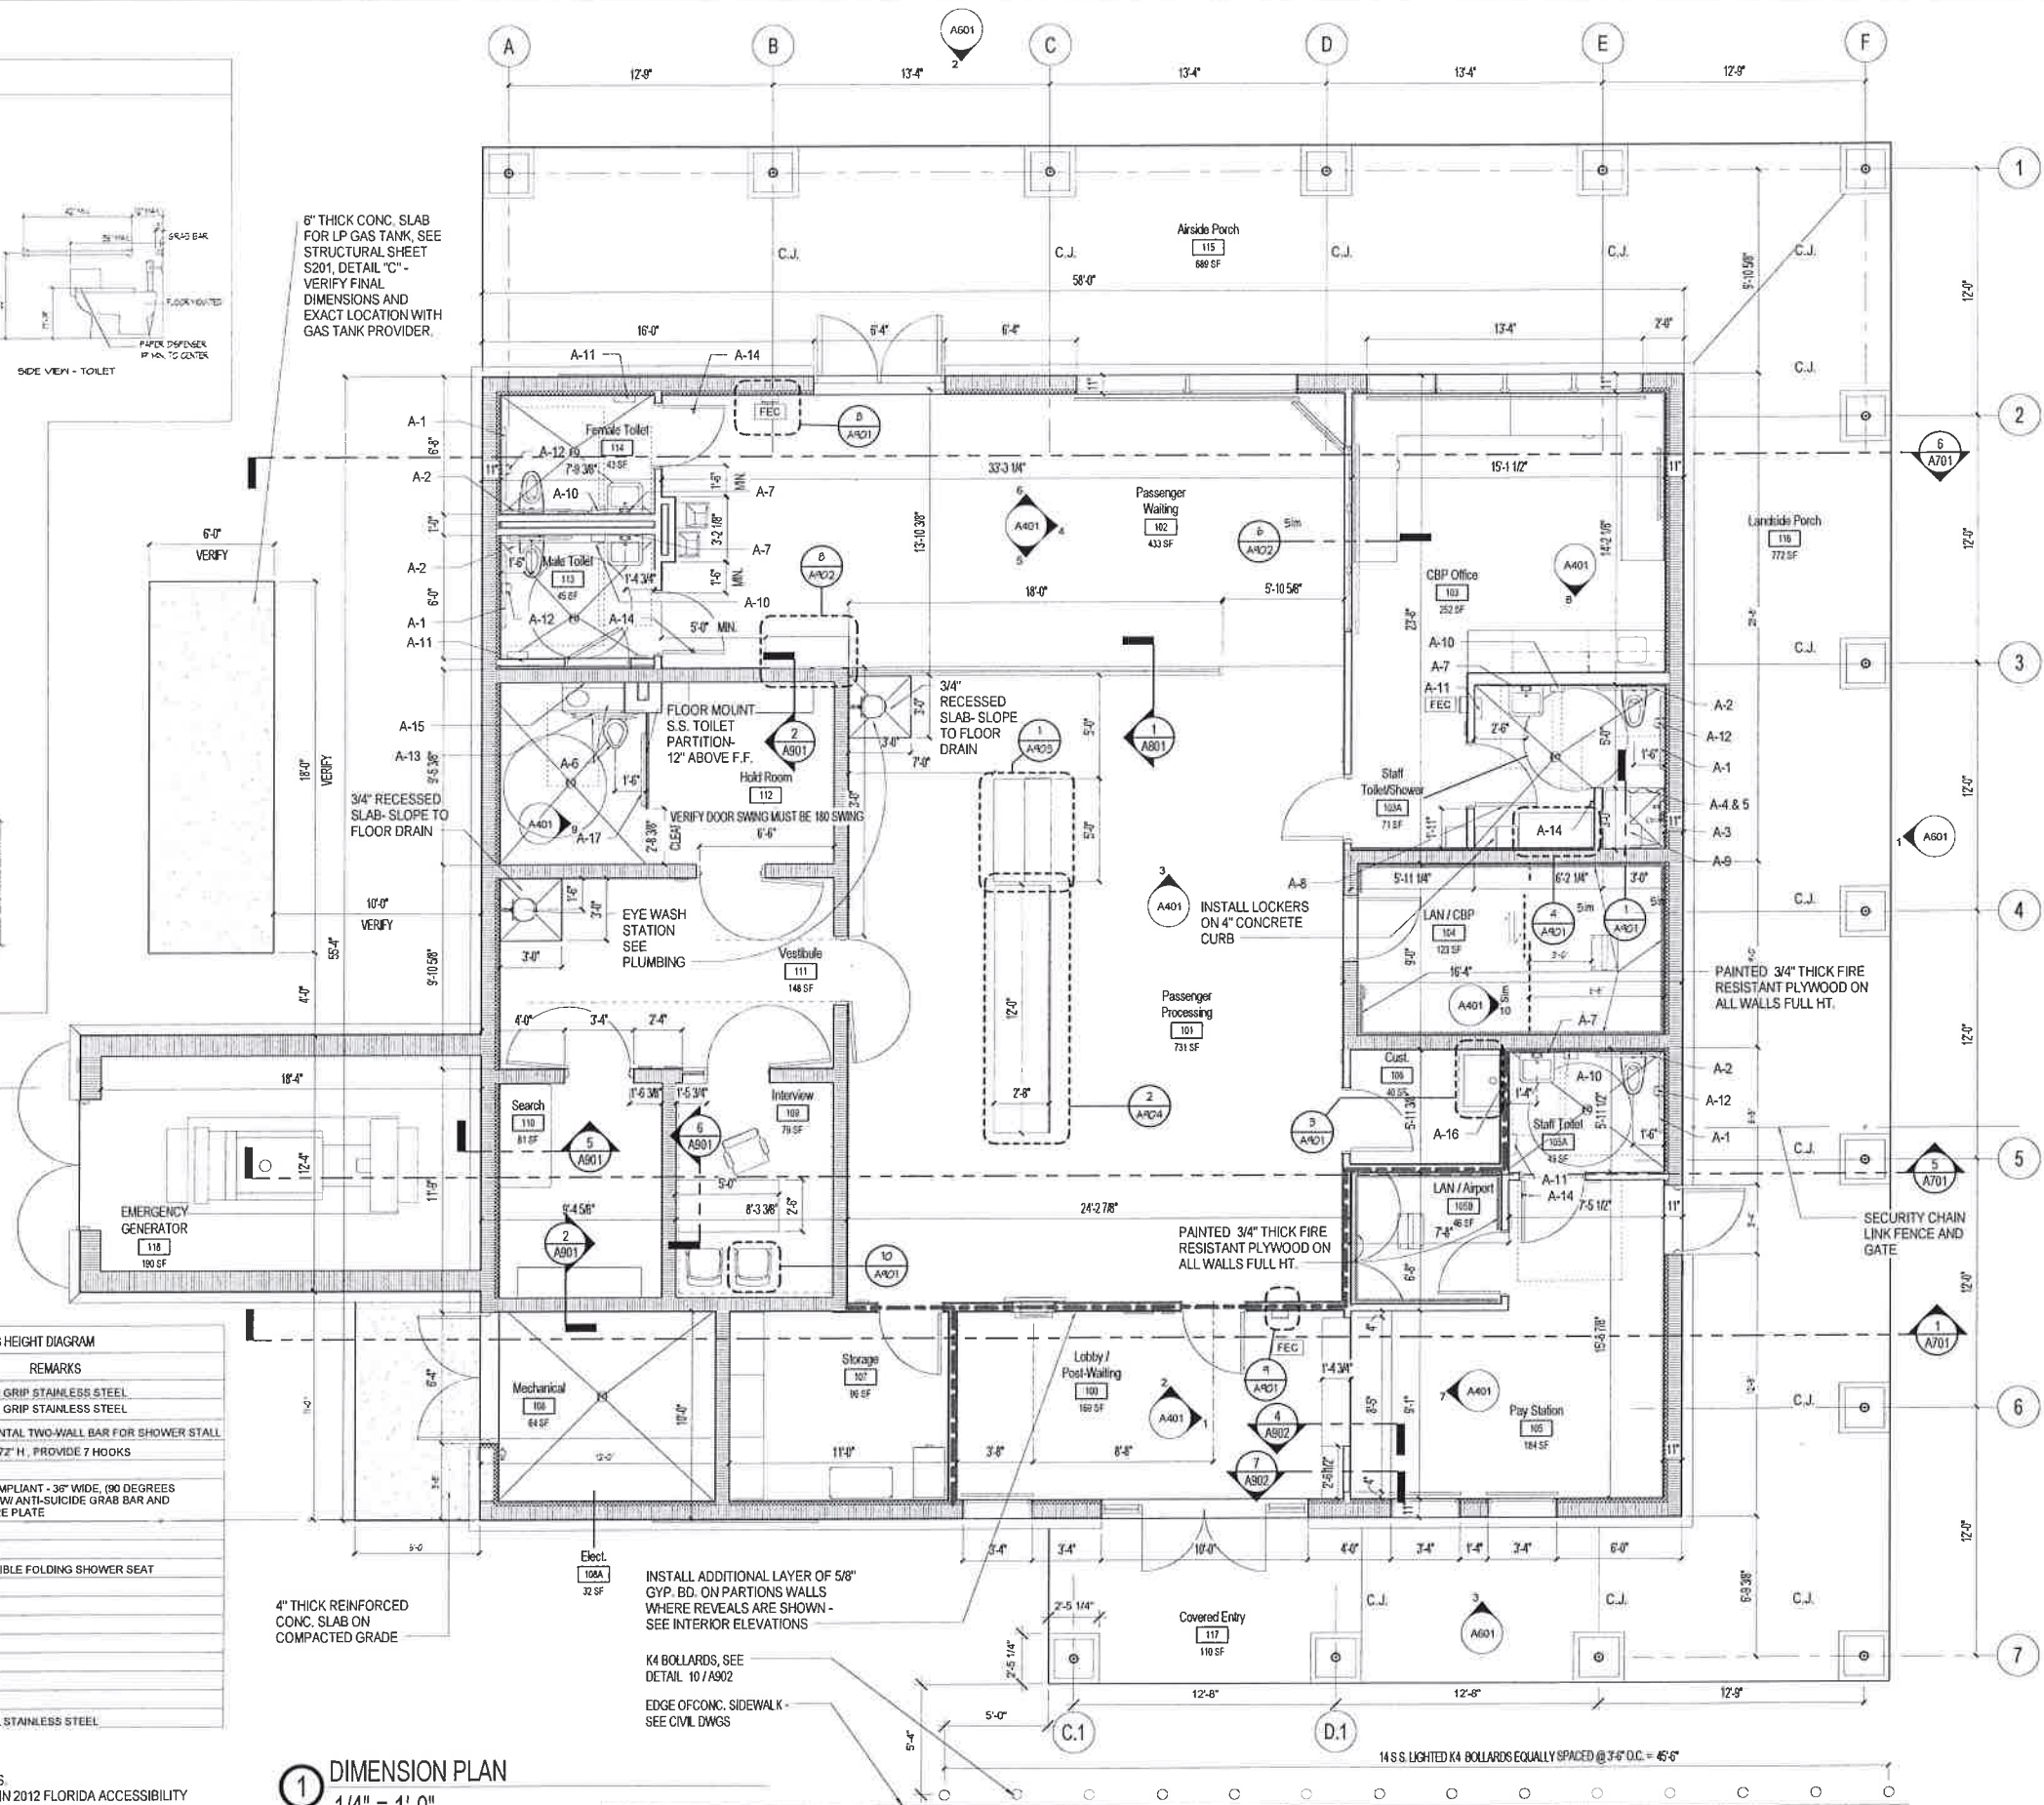

① DIMENSION PLAN
1/4" = 1'-0"

INSTALL ADDITIONAL LAYER OF
GYPS. BD. ON PARTITION WALLS
WHERE REVEALS ARE SHOWN
SEE INTERIOR ELEVATIONS

K4 BOLLARDS, SEE
DETAIL 10/A902

EDGE OF CONC. SIDEWALK -
SEE CIVIL DWGS

14 S.S. LIGHTED K4 BOLLARDS EQUALLY SPACED @ 3'-6" O.C. = 45'-6"